


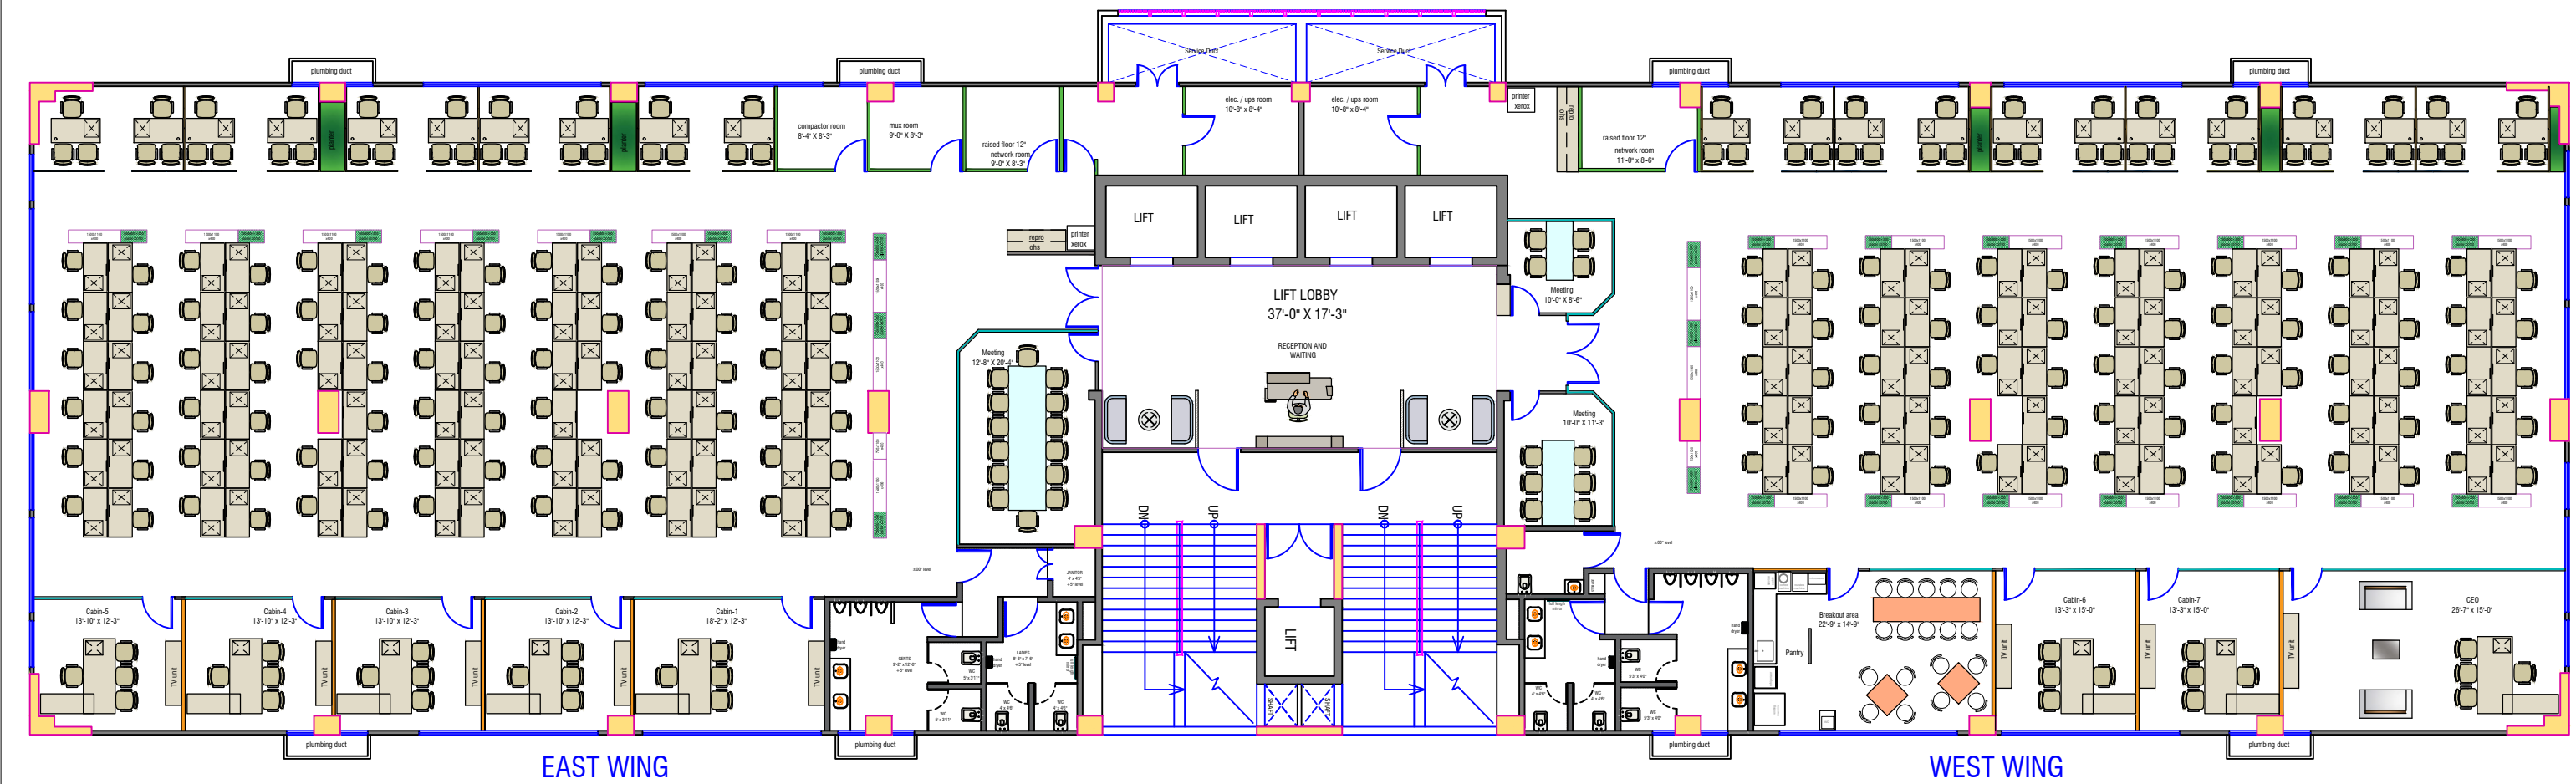


- * ALL DRAWINGS ARE THE PROPERTY OF THE DESIGNER.
- * DRAWINGS NOTE BE MEASURED ONLY WRITTEN DIMENSIONS ARE TO BE FOLLOWED.
- * ALL THE DRAWINGS ARE IN BRITISH SYSTEM UNLESS OTHERWISE SPECIFIED.
- * ALL DRAWINGS ARE TO BE READ IN CONNECTION WITH RELEVANT ARCHITECTURAL AND STRUCTURAL DETAILS.
- * IF ANY CHANGES REQUIRED AT THE TIME OF EXECUTION ,IT SHOULD BE DISCUSSED AND GOT IT APPROVED BY THE DESIGNER,

INTERIOR SITE FOR,

Commerce House 6

At - Ahmedabad

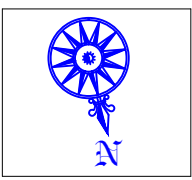

Checked : J.P.
Designer : ANIL

Date : 19-07-2022
Scale: N.T.S

Dwg. NO:

74

DESIGNED BY :




insight
aim architects
interiors
modulars

13, Shivallik Arcade, Opp. Prahladnagar AJUDA Garden
Satellite Ahmedabad. Ph: 079- 26931550/26931610

- Dome Camera - 20
- Fisheye Camera - 06
- ☁ Card Base Access - 07
- ☁ FR Base Access - 02
(Cabling for both FR & Card)
- Access Panel - 01
(As per Design - Wall Mount)
- DPS - 02

- Note - Point to be discuss for infra related
1. Cabling route for IT infra design
 2. Access control panel size (Approx -H1.5mtr XW1.5Mtr X D200mm) and location to be confirm
 3. separate access control panel for both wing
 4. UPS power provision for Access panel at each floor
 5. all rooms and office area door design for access control lock mounting
 6. server mounting space in rack for security server - 2nos
 7. control room setup
 8. Other floor like GF, 10th & basement to be confirm
 9. other sites location camera monitoring requirement - critical camera list for network bandwidth requirement
 9. MPLS charges to be confirm and add in BOQ or fiber connectivity for CH7 to CH6 to be check

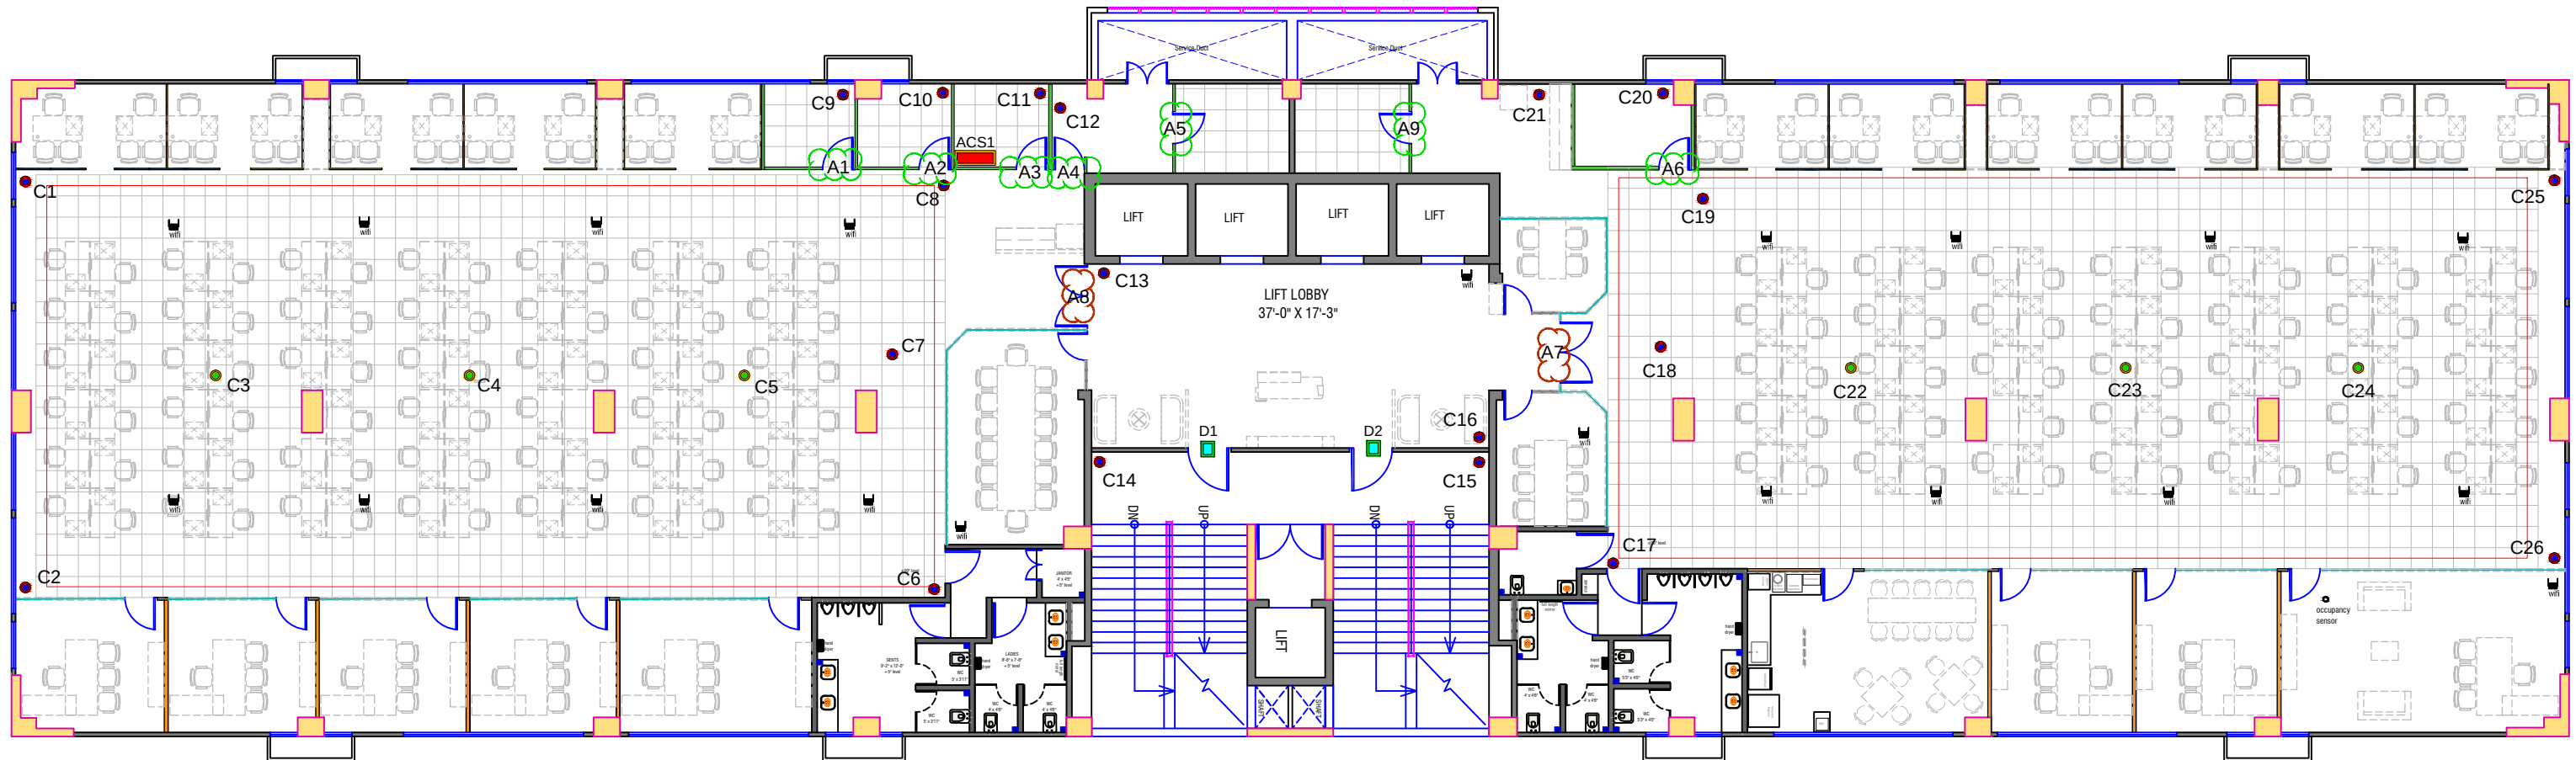

Security and automation System Layout

* ALL DRAWINGS ARE THE PROPERTY OF THE DESIGNER.
* DRAWINGS NOTE BE MEASURED ONLY WRITTEN DIMENSIONS ARE TO BE FOLLOWED.
* ALL THE DRAWINGS ARE IN BRITISH SYSTEM UNLESS OTHERWISE SPECIFIED.
* ALL DRAWINGS ARE TO BE READ IN CONNECTION WITH RELEVANT ARCHITECTURAL AND STRUCTURAL DETAILS.
* IF ANY CHANGES REQUIRED AT THE TIME OF EXECUTION ,IT SHOULD BE DISCUSSED AND GOT IT APPROVED BY THE DESIGNER,

INTERIOR SITE FOR,

Commerce House 6

At - Ahmedabad



Checked : J.P.

Designer : ANIL

Date : 19-07-2022

Scale: N.T.S

Dwg. NO:

98

DESIGNED BY :
insight
architects
interiors
modulars
13,Shivalki Arcade,Opp. Prahladnagar AUDA Garden
Satellite,Ahmedabad. Ph: 079- 26931550/26931610



Smoke Detector, Speaker, Sprinkler layout

* ALL DRAWINGS ARE THE PROPERTY OF THE DESIGNER.
 * DRAWINGS NOTE BE MEASURED ONLY WRITTEN DIMENSIONS ARE TO BE FOLLOWED.
 * ALL THE DRAWINGS ARE IN BRITISH SYSTEM UNLESS OTHERWISE SPECIFIED.
 * ALL DRAWINGS ARE TO BE READ IN CONNECTION WITH RELEVANT ARCHITECTURAL AND STRUCTURAL DETAILS.
 * IF ANY CHANGES REQUIRED AT THE TIME OF EXECUTION ,IT SHOULD BE DISCUSSED AND GOT IT APPROVED BY THE DESIGNER,

INTERIOR SITE FOR,

Commerce House 6

At - Ahmedabad



Checked : J.P.

Designer : ANIL


Date : 19-07-2022

Scale: N.T.S

Dwg. NO:

99

DESIGNED BY :
insight
 architects
 interiors
 modulars
 13,Shivalki Arcade,Opp. Prahladnagar AUDA Garden
 Satellite,Ahmedabad. Ph: 079- 26931550/26931610

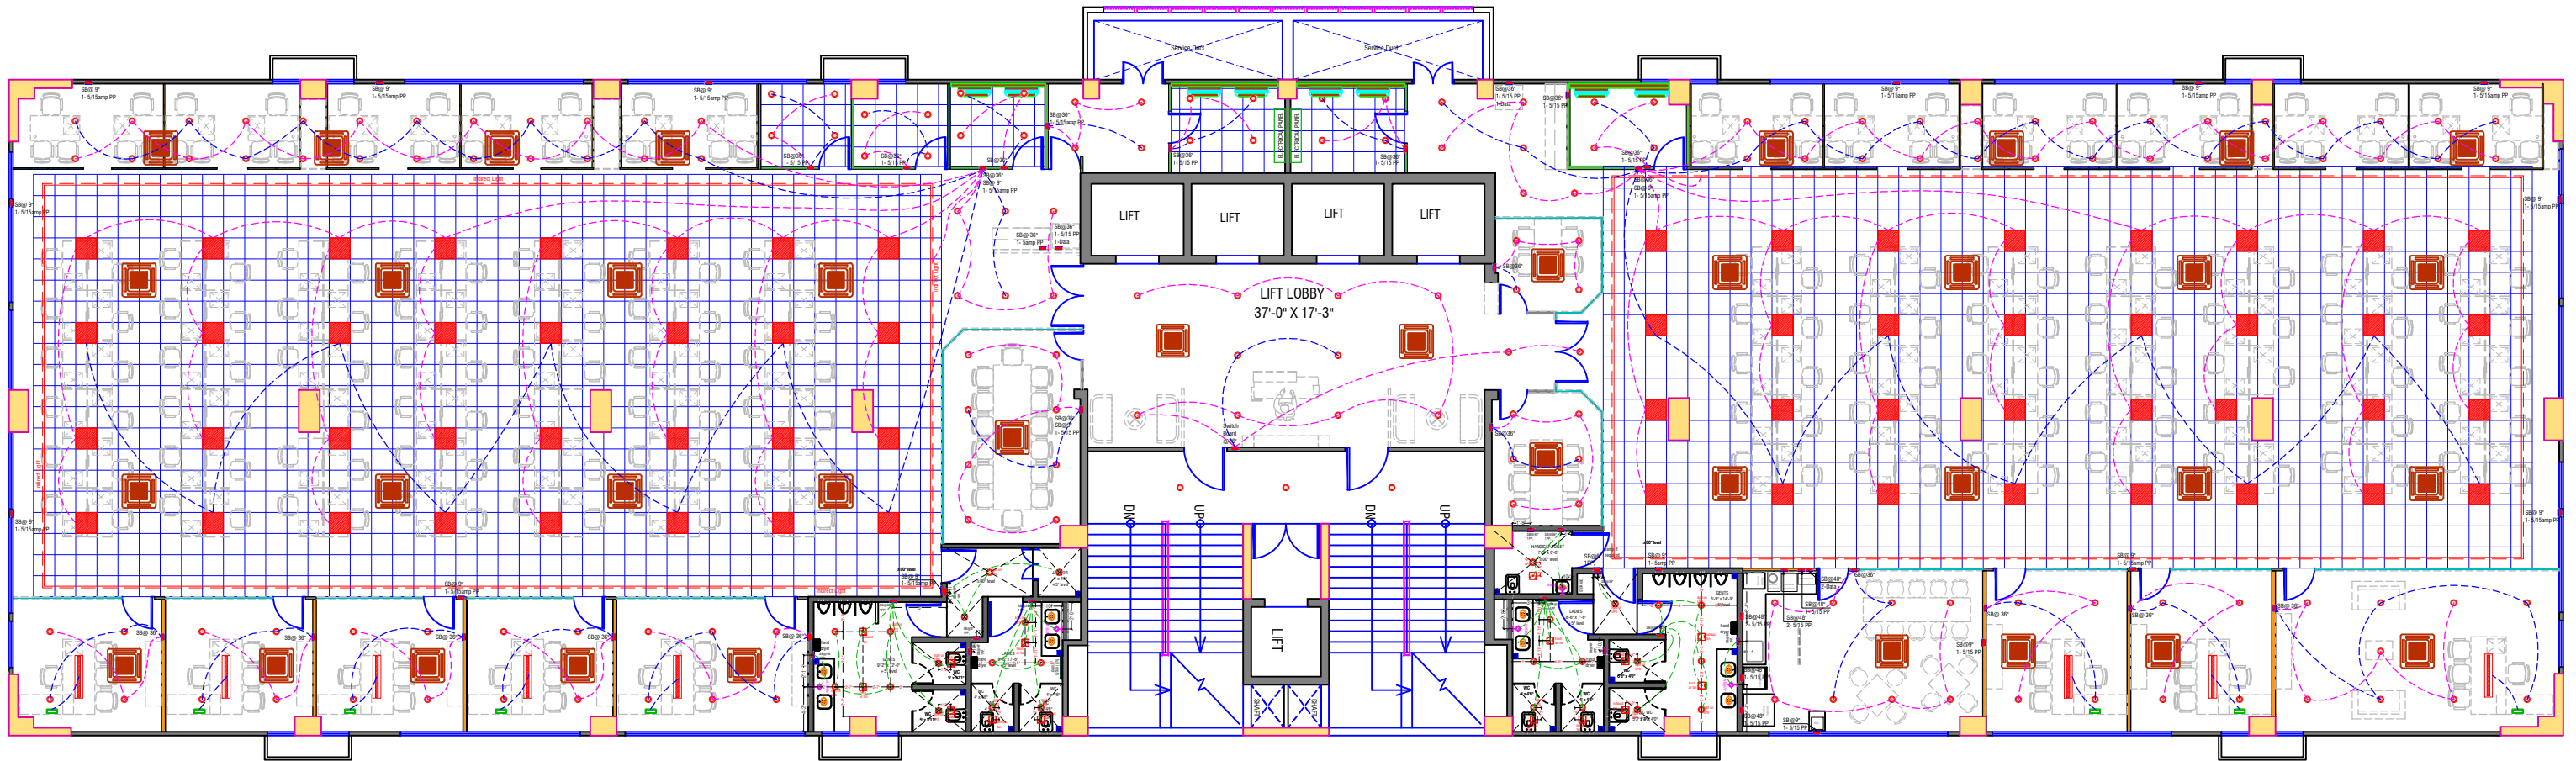

Light & Looping layout of 1st Floor

600 X 600
PANEL LIGHT


DOWNLIGHT

UPS light wiring

Power light wiring

* ALL DRAWINGS ARE THE PROPERTY OF THE DESIGNER.
 * DRAWINGS NOTE BE MEASURED ONLY WRITTEN DIMENSIONS ARE TO BE FOLLOWED.
 * ALL THE DRAWINGS ARE IN BRITISH SYSTEM UNLESS OTHERWISE SPECIFIED.
 * ALL DRAWINGS ARE TO BE READ IN CONNECTION WITH RELEVANT ARCHITECTURAL AND STRUCTURAL DETAILS.
 * IF ANY CHANGES REQUIRED AT THE TIME OF EXECUTION ,IT SHOULD BE DISCUSSED AND GOT IT APPROVED BY THE DESIGNER,

INTERIOR SITE FOR,
Commerce House 6
 At - Ahmedabad

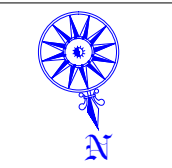


Checked : J.P.
 Designer : ANIL

Date : 19-07-2022
 Scale: N.T.S


Dwg. NO:
106

DESIGNED BY :

 13,Shivalki Arcade,Opp. Prahladnagar AUDA Garden
 Satellite,Ahmedabad. Ph: 079- 26931550/26931610

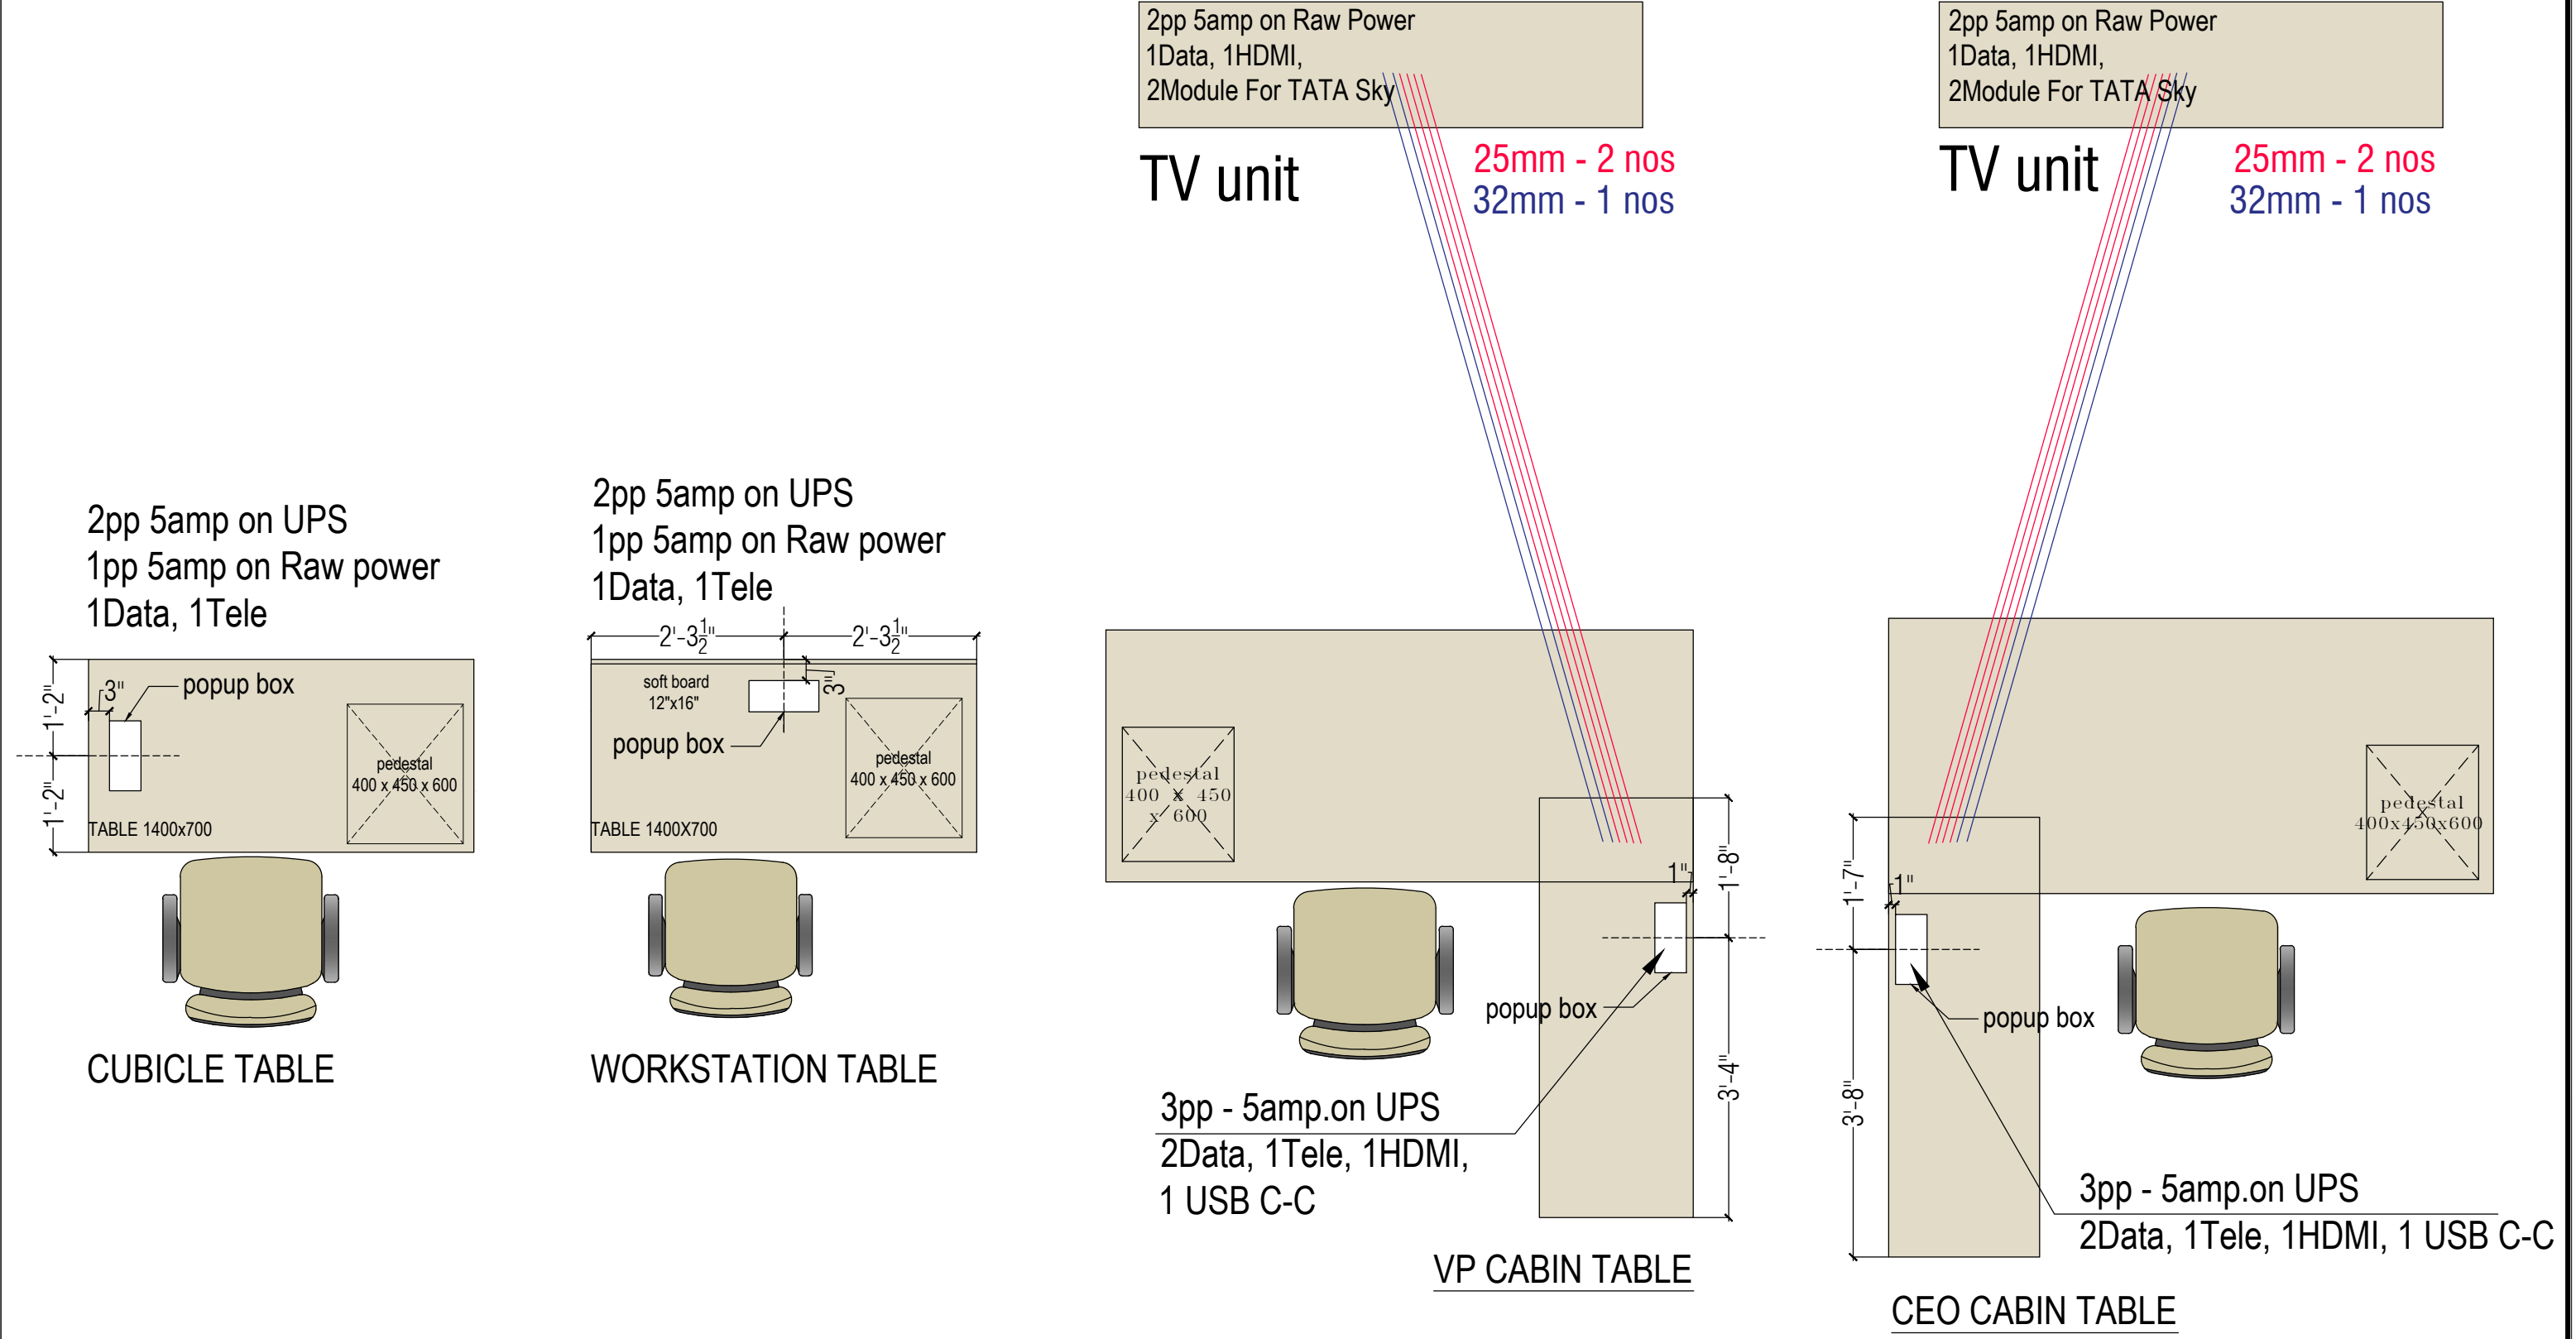

Typical detail-1 - Electrical and Data Point per Table

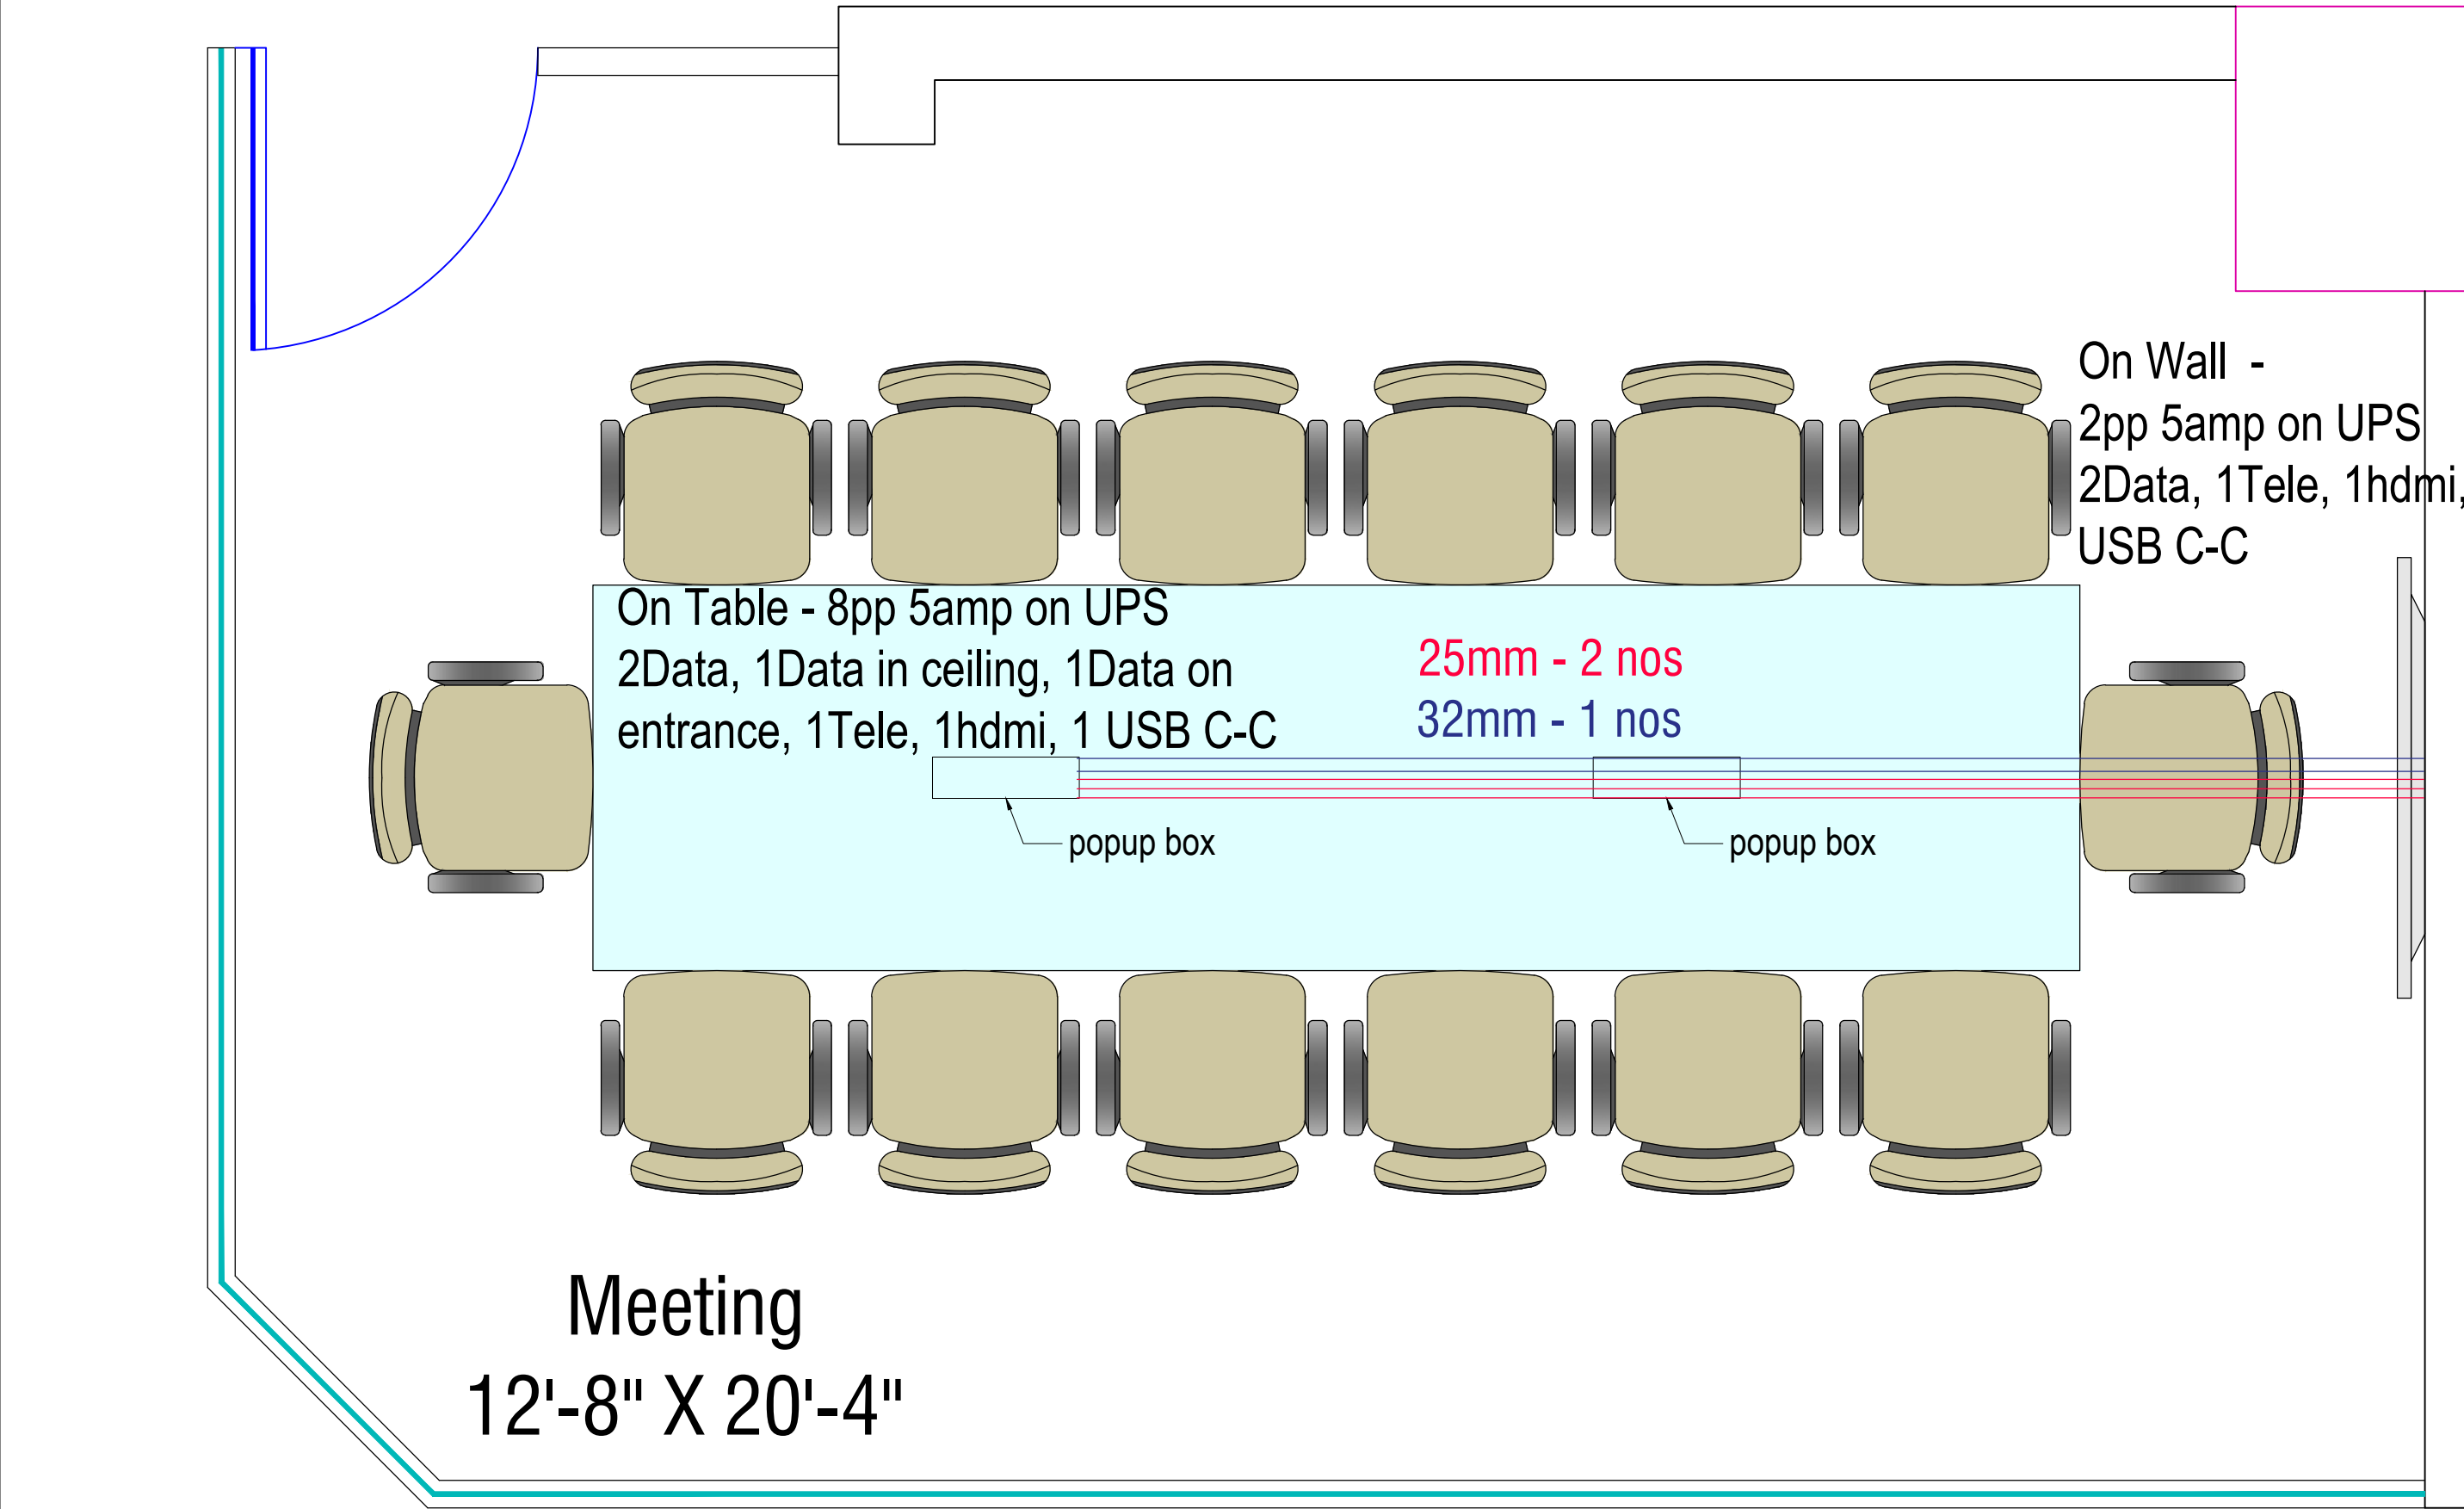

Typical detail-2 - Electrical and Data Point per Table

* ALL DRAWINGS ARE THE PROPERTY OF THE DESIGNER.
* DRAWINGS NOTE BE MEASURED ONLY WRITTEN DIMENSIONS ARE TO BE FOLLOWED.
* ALL THE DRAWINGS ARE IN BRITISH SYSTEM UNLESS OTHERWISE SPECIFIED.
* ALL DRAWINGS ARE TO BE READ IN CONNECTION WITH RELEVANT ARCHITECTURAL AND STRUCTURAL DETAILS.
* IF ANY CHANGES REQUIRED AT THE TIME OF EXECUTION ,IT SHOULD BE DISCUSSED AND GOT IT APPROVED BY THE DESIGNER,

INTERIOR SITE FOR,

Commerce House 6

At - Ahmedabad



Checked : J.P.

Designer : ANIL

Date : 19-07-2022

Scale: N.T.S

Dwg. NO:

108

- * ALL DRAWINGS ARE THE PROPERTY OF THE DESIGNER.
- * DRAWINGS NOTE BE MEASURED ONLY WRITTEN DIMENSIONS ARE TO BE FOLLOWED.
- * ALL THE DRAWINGS ARE IN BRITISH SYSTEM UNLESS OTHERWISE SPECIFIED.
- * ALL DRAWINGS ARE TO BE READ IN CONNECTION WITH RELEVANT ARCHITECTURAL AND STRUCTURAL DETAILS.
- * IF ANY CHANGES REQUIRED AT THE TIME OF EXECUTION ,IT SHOULD BE DISCUSSED AND GOT IT APPROVED BY THE DESIGNER,

Date : 19-07-2022
Scale: N.T.S

DESIGNED BY :



insight
aim architects
interiors
modulars


13, Shivalik Arcade, Opp. Prahladnagar AUDA Garden
Satellite, Ahmedabad. Ph: 079- 26931550/26931610



Light, Looping, Sprinkler, Smoke Detector, AC & Security System layout of 1st Floor

* ALL DRAWINGS ARE THE PROPERTY OF THE DESIGNER.
 * DRAWINGS NOTE BE MEASURED ONLY WRITTEN DIMENSIONS ARE TO BE FOLLOWED.
 * ALL THE DRAWINGS ARE IN BRITISH SYSTEM UNLESS OTHERWISE SPECIFIED.
 * ALL DRAWINGS ARE TO BE READ IN CONNECTION WITH RELEVANT ARCHITECTURAL AND STRUCTURAL DETAILS.
 * IF ANY CHANGES REQUIRED AT THE TIME OF EXECUTION ,IT SHOULD BE DISCUSSED AND GOT IT APPROVED BY THE DESIGNER,

INTERIOR SITE FOR,
Commerce House 6
 At - Ahmedabad

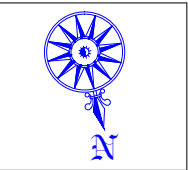

Checked : J.P.
 Designer : ANIL

Date : 19-07-2022
 Scale: N.T.S

Dwg. NO:
110

DESIGNED BY :
insight
 architects
 interiors
 modulars
 13,Shivalki Arcade,Opp. Prahladnagar AUDA Garden
 Satellite,Ahmedabad. Ph: 079- 26931550/26931610